

SITE INVESTIGATION NOTE

EXAMINATION OF CONTRACT DOCUMENTS AND SITE OF WORK: THE BIDDER IS REQUIRED, BEFORE SUBMITTING HIS PROPOSAL, TO VISIT THE SITE OF THE PROPOSED WORK AND FAMILIARIZE HIM OR HERSELF WITH THE NATURE AND EXTENT OF THE WORK AND ANY LOCAL CONDITIONS THAT MAY IN ANY MANNER AFFECT THE WORK TO BE DONE AND EQUIPMENT, MATERIALS AND LABOR REQUIRED THEREFORE. SINCE THE WORK INVOLVES NEW AND/OR EXISTING BUILDINGS, SYSTEMS AND FACILITIES, SPECIAL CONSIDERATION SHALL BE GIVEN TO EXAMINATION OF WORKING CONDITIONS, NEW FACILITIES AND ALL BUILDING STRUCTURES FAMILIARIZE TO HIMSELF WITH ALL EXISTING CONDITIONS. SLIGHT VARIATION OF ROUTING AND OR CONSTRUCTIONS SHOULD BE ANTICIPATED BY THIS CONTRACTOR TO AVOID CONFLICTS WITH OTHER TRADES. THESE VARIATIONS ARE EXPRESSLY INCLUDED AS PART OF THE WORK WHENEVER REQUIRED AT NO ADDITIONAL COST TO THE OWNER. IGNORANCE ON THE PART OF THE CONTRACTOR WILL IN NO WAY RELIEVE HIM OF THE OBLIGATIONS AND RESPONSIBILITY ASSUMED UNDER THIS CONTRACT.


LUMINAIRE SCHEDULE

Symbol	Label	Qty	Catalog Number	Description	Lamp	Number Lamps	Lumens per Lamp	LLF	Watts	Polar Plot
	A	13	VUE-2-T2-96L-1050-40K-UNV	27.06"L X 21.56"W X 8"H LED LUMINARIES ALUMINUM REFLECTOR WITH CLEAR LENS.		1	31830	1	316	25°-0°
	B	13	Model # 7787-05B or equal	8.7"L X 8.7"W X 16.2"H LED Exterior Lighting Product Type Post and Lamp Sets	Light Bulb Base Code E26	1	—	—	60	6°-0°

Statistics

Description	Symbol	Avg	Max	Min	Max/Min	Avg/Min
Calc. Zone #1		5.6 fc	12.4 fc	1.1 fc	11.3:1	5.1:1

1. Please Contact: Giovanni A. Perez at Contemporary Lighting Sales
786-344-2660 or (GAP0210@GMAIL.COM)
For procurement of the specified lighting equipment.

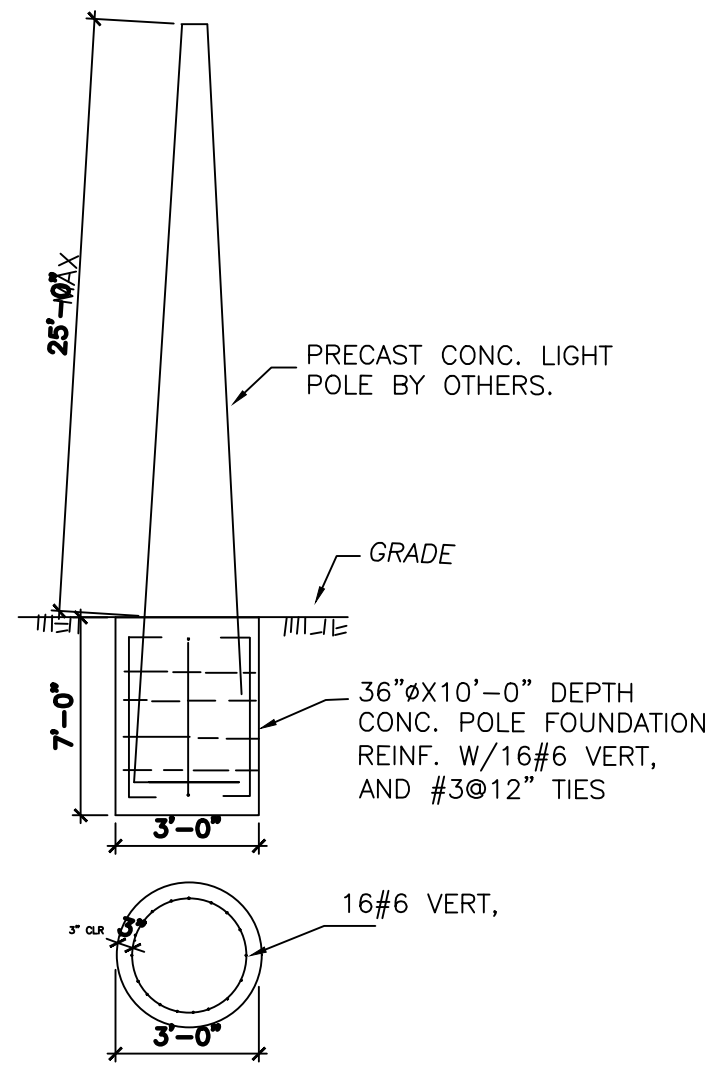


POLE 25' MOUNTING DETAIL

PHOTOMETRIC SITE PLAN

SCALE: 1/32"= 1'-0"


R1 - SINGLE FAMILY DWELLING RESIDENTIAL

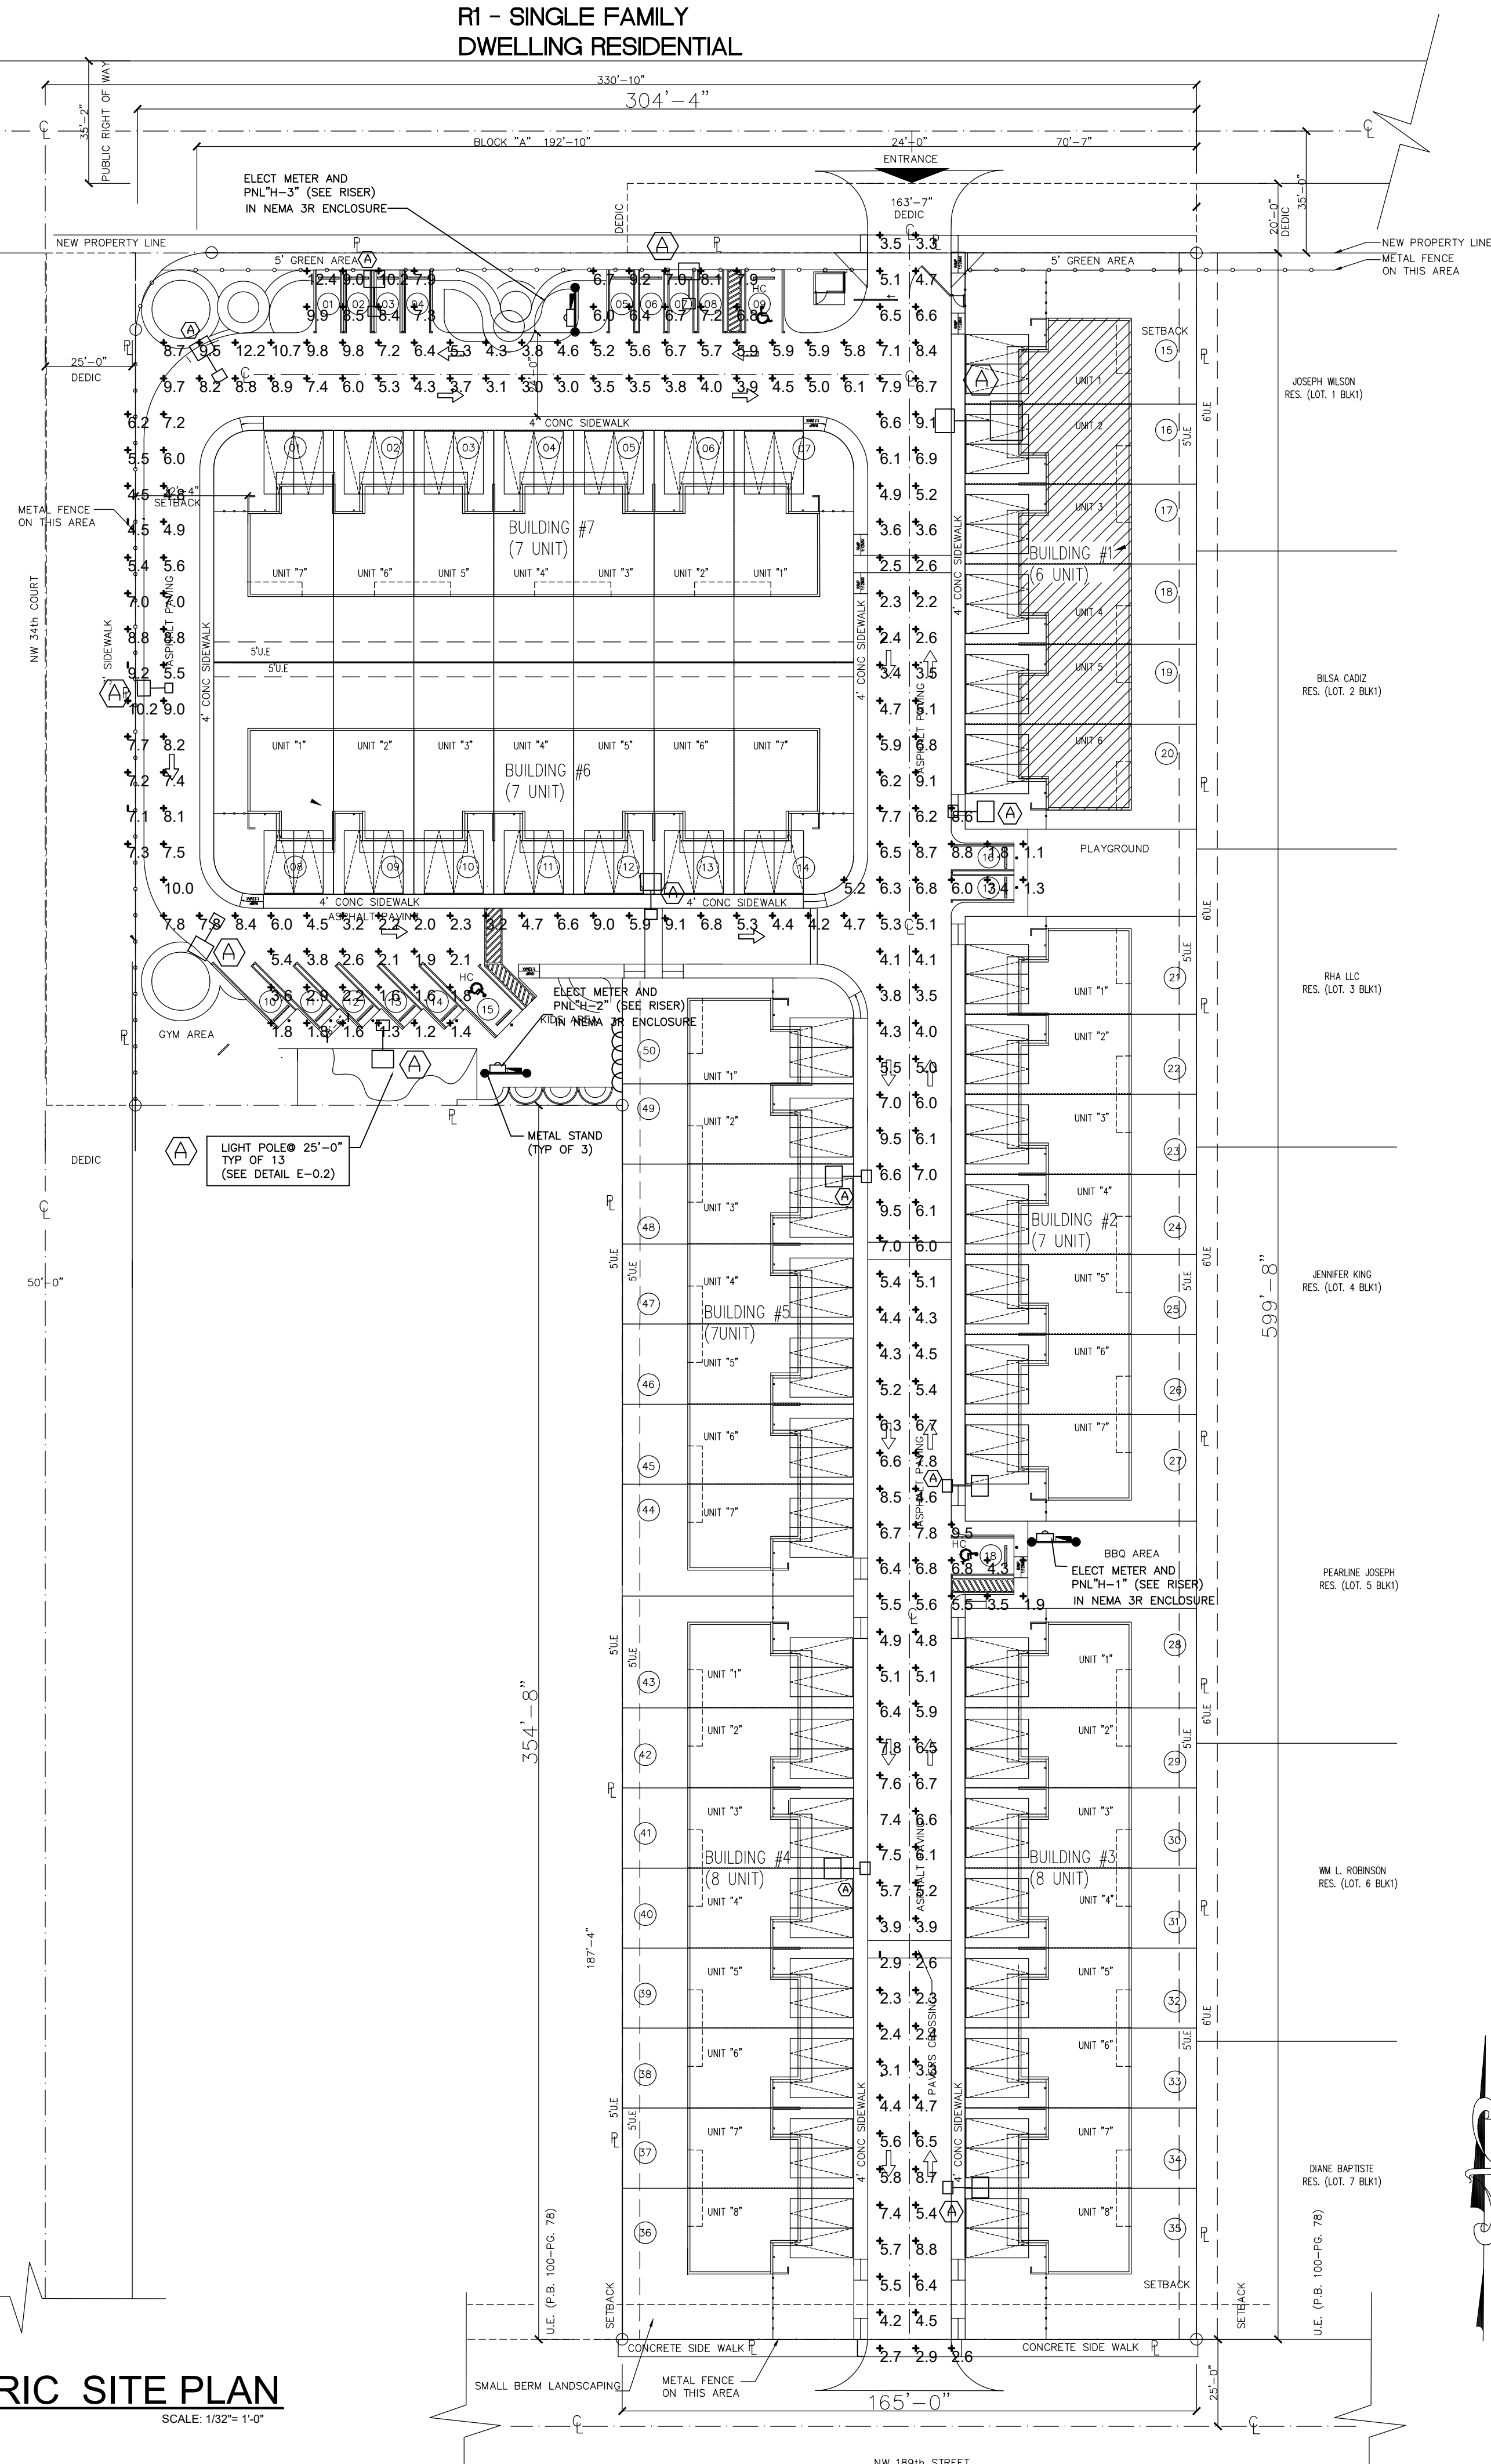

Revisions
02.01.19 1ST ISSUE

PROPOSED NEW BLDG 1 (6 UNIT APT COMPLEX)
THE VILLAGES AT MIAMI GARDENS
3400 NW 191st STREET
MIAMI GARDENS, FL 33056-2936

JCD ARCHITECT, Inc.
JUAN C. DAVID R.A. # 0015344
Design & Development
LEED ACCREDITED PROFESSIONAL
Architecture Interiors Planning Construction
1385 Coral Way, Suite 404 Miami, Florida 33145
Phone: (305) 285-4343 Fax: (305) 285-4330

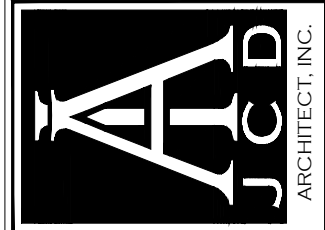

Job No.
Date
Scale SHOWN

Seal
AA-26001560
Sheet No.
E-0.2