



Schedule					
Symbol	Label	QTY	Catalog Number	Number Lamps	Lumens per Lamp
○	A	12	DLSS6-2012-120K4KWH	1	1200/49
				Lamp	24 white LEDs
				Description	Circular white aluminum housing with clear inner lens and frosted outer lens
				LLF	1
				Wattage	17.539

Statistics					
Description	Symbol	Avg	Max	Min	Max/Min
Calc Zone #1	+	16.2 fc	19.5 fc	13.4 fc	1.5:1
Calc Zone #1(Copy)	+	16.2 fc	19.5 fc	13.4 fc	1.5:1
Calc Zone #1(Copy)	+	16.2 fc	19.5 fc	13.4 fc	1.5:1
Calc Zone #1(Copy)	+	16.2 fc	19.5 fc	13.4 fc	1.5:1
Calc Zone #1(Copy)	+	16.2 fc	19.5 fc	13.4 fc	1.5:1
Calc Zone #1(Copy)	+	16.2 fc	19.5 fc	13.4 fc	1.5:1


1. Please Contact: Giovanni A. Perez at Contemporary Lighting Sales
786-344-2660 or (GAP0210@GMAIL.COM)
For procurement of the specified lighting equipment.

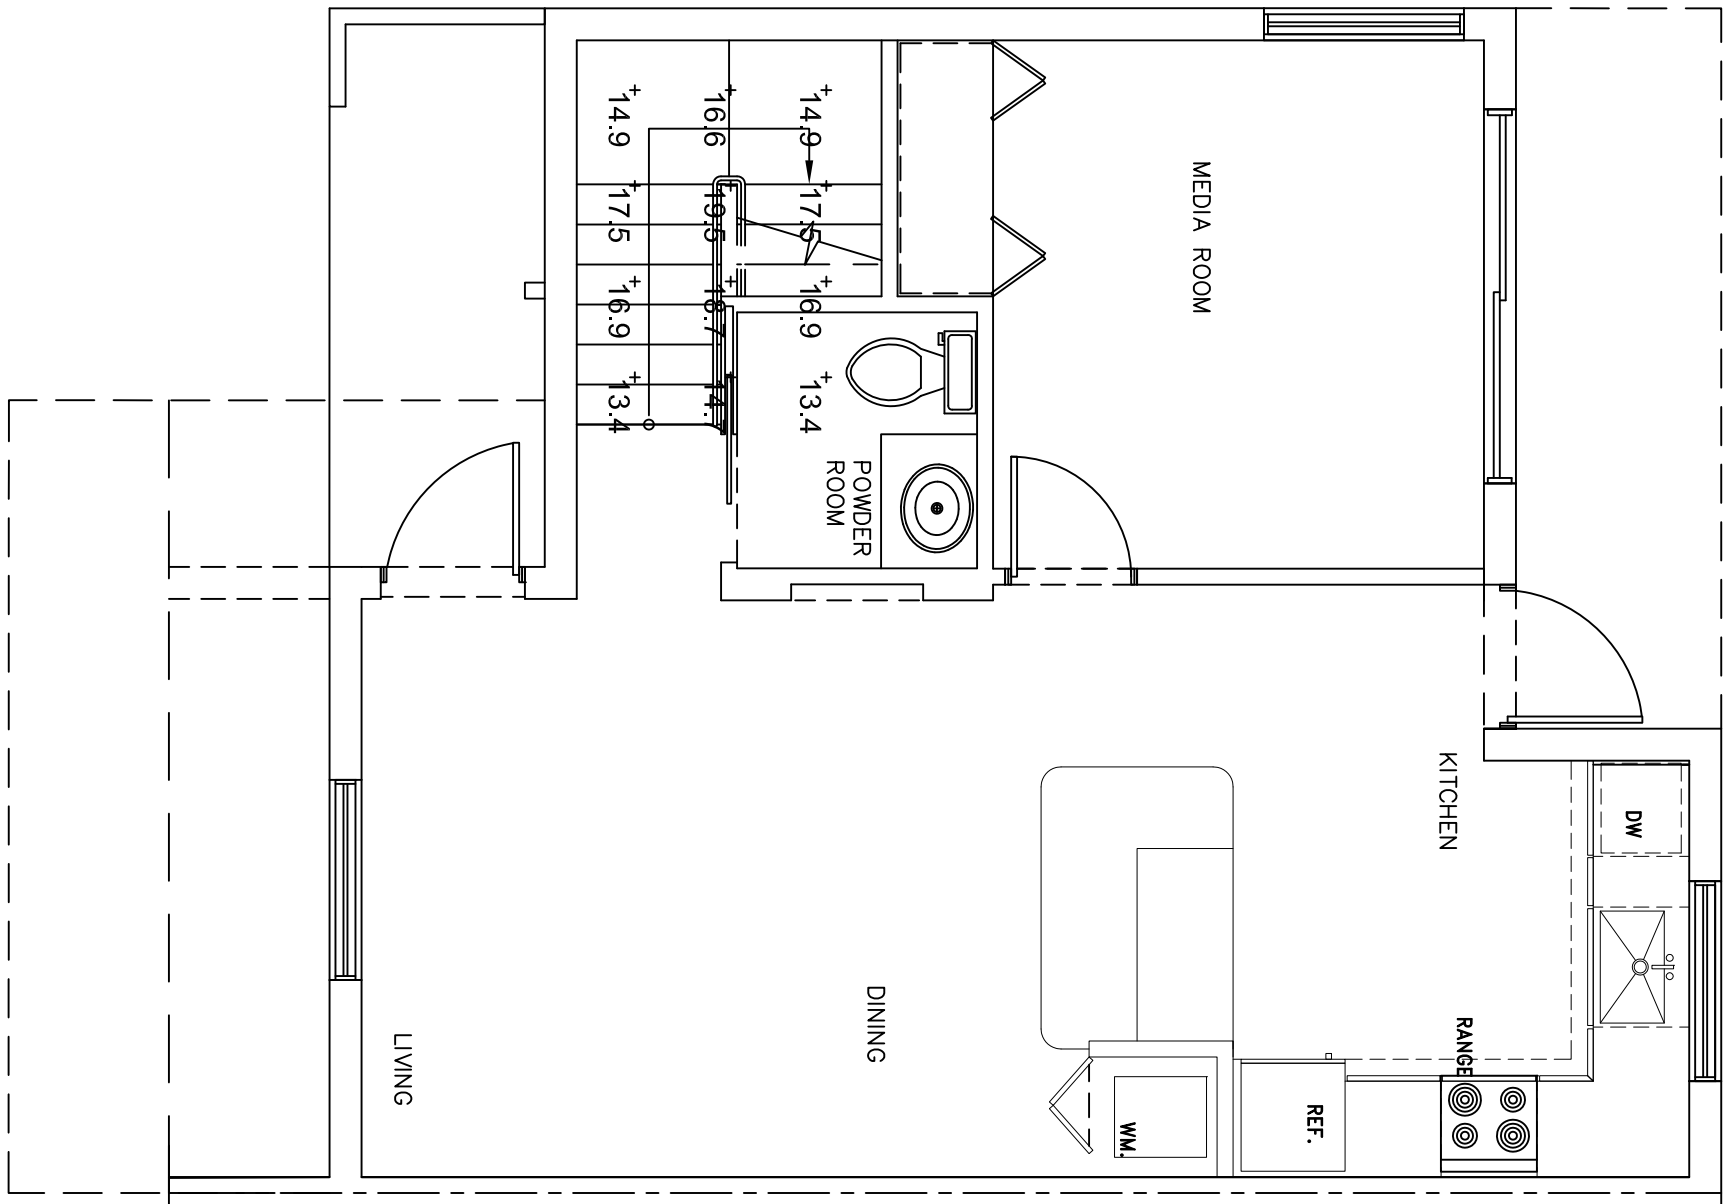


GROUND FLOOR PLAN -CORNER
TYP (UNITS)

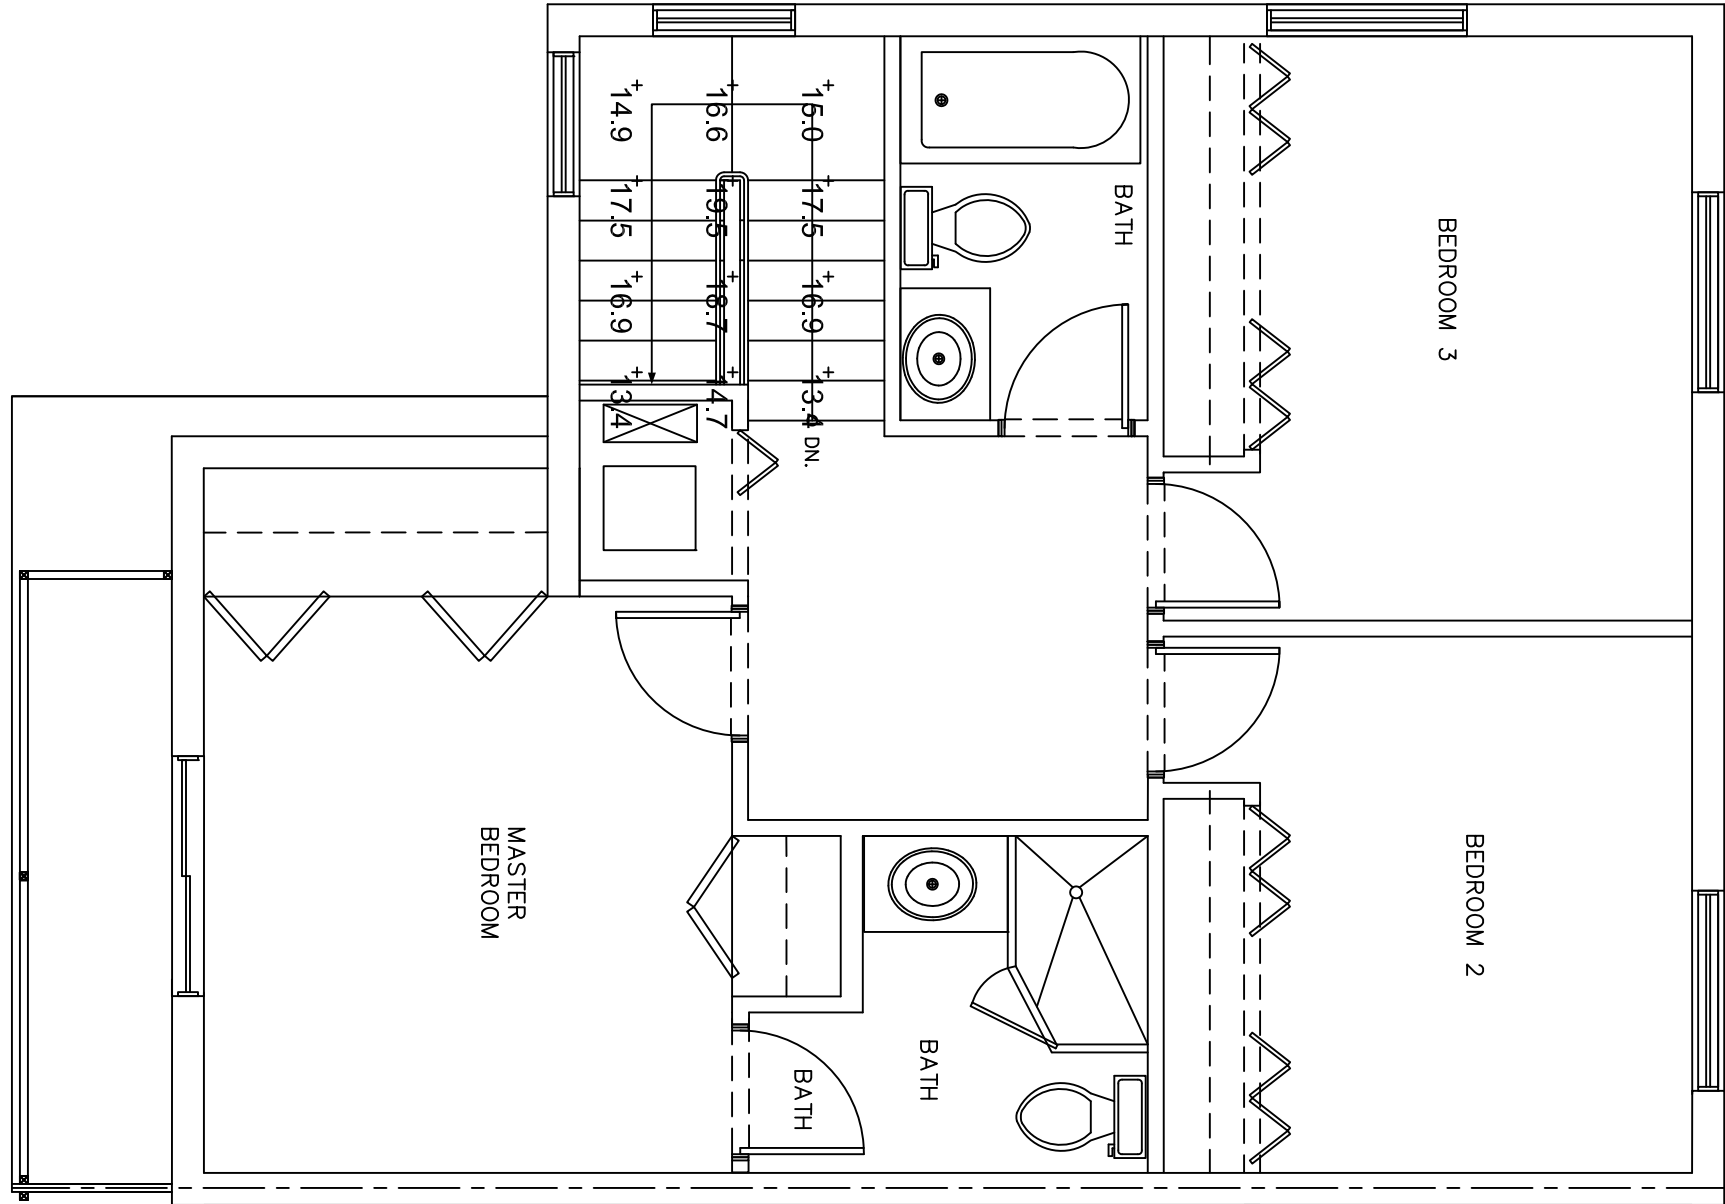

SECOND FLOOR PLAN -CORNER
TYP (UNITS)

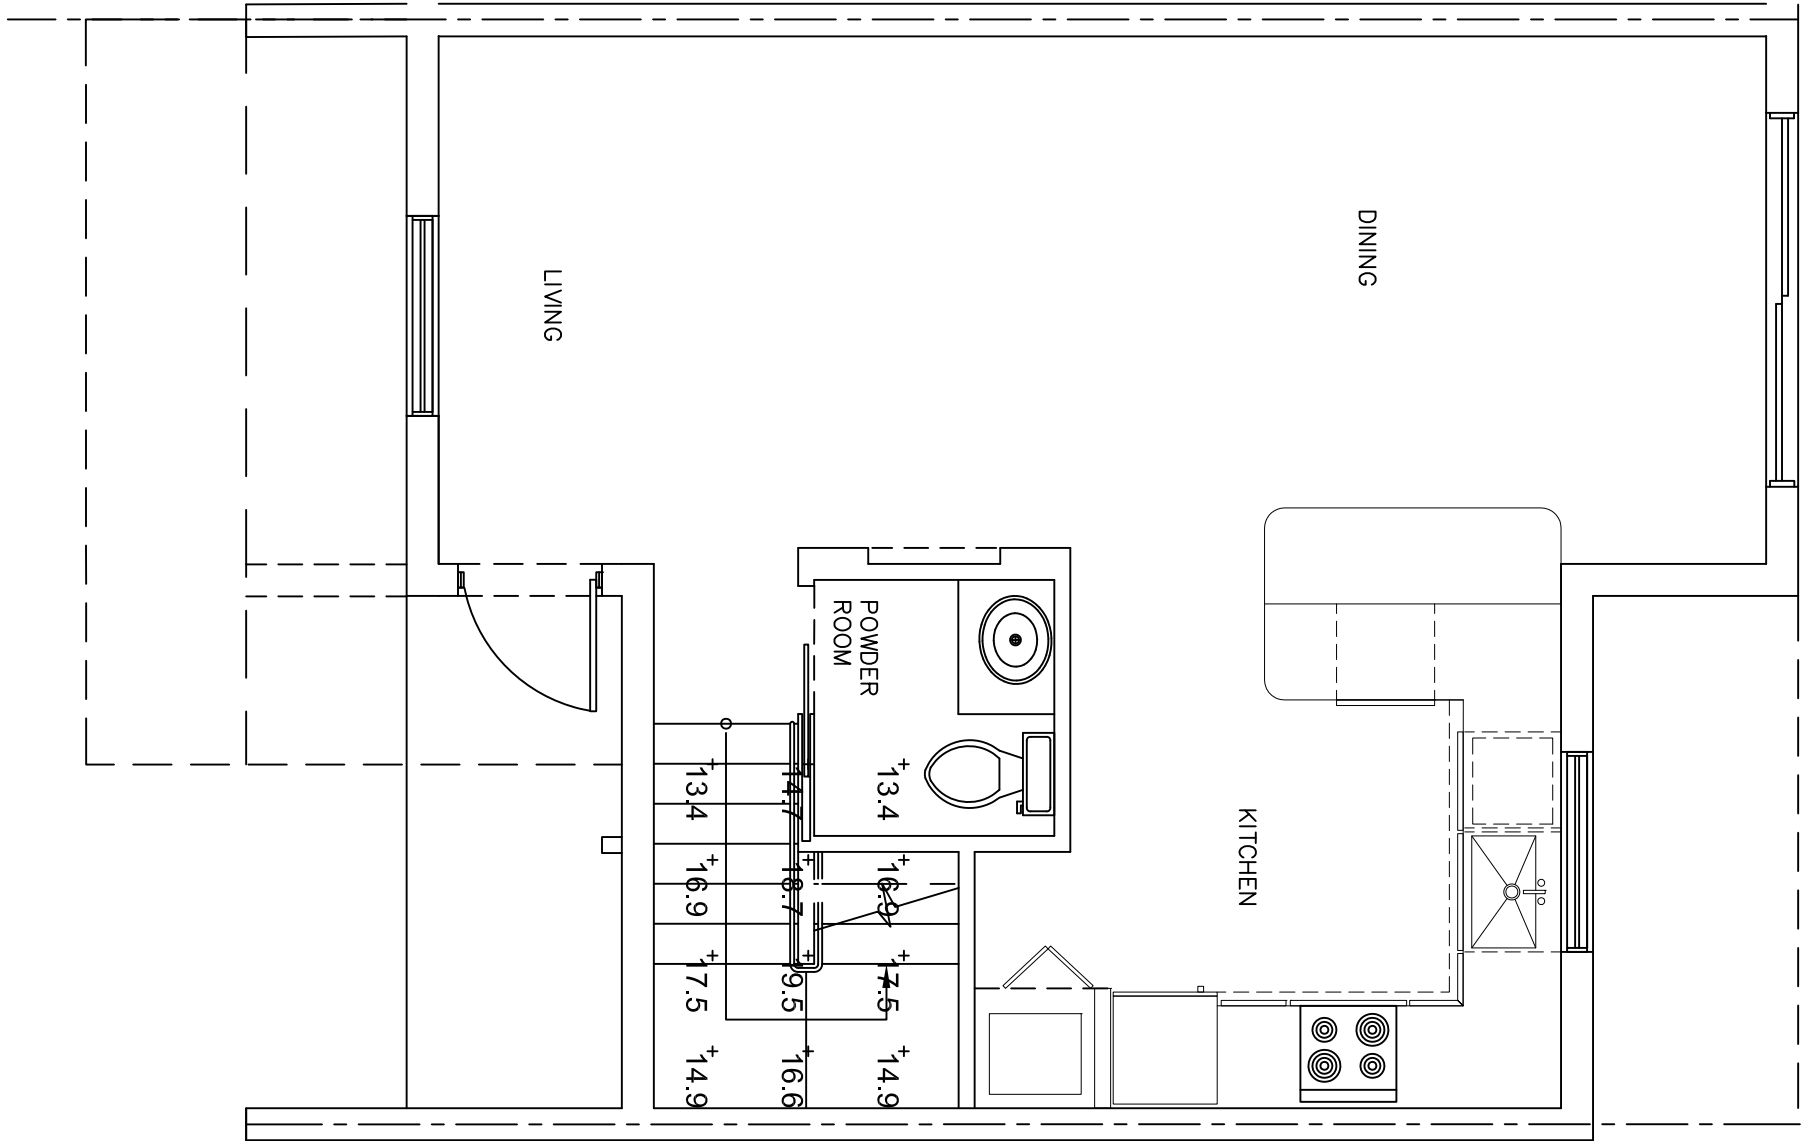


GROUND FLOOR PLAN -CORNER
TYP (UNITS)

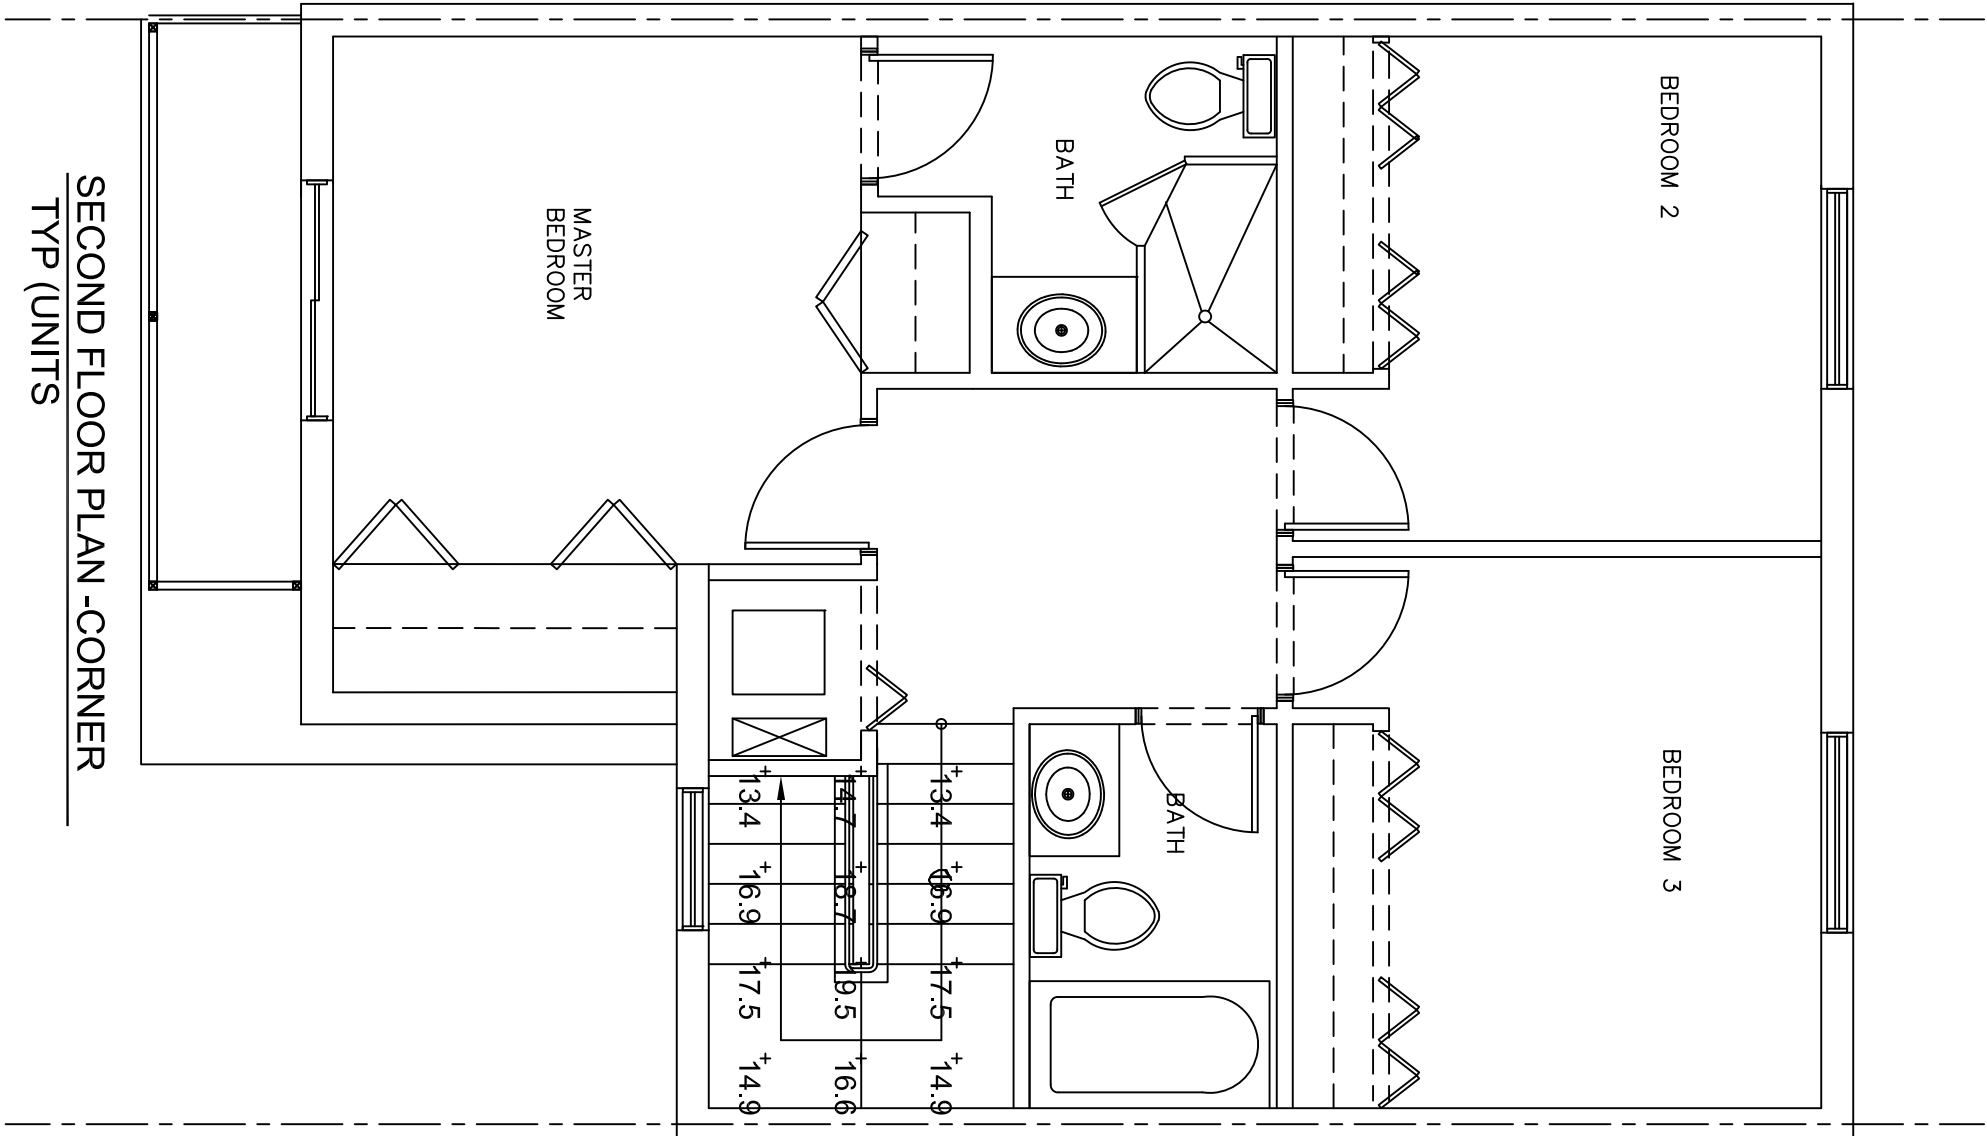

SECOND FLOOR PLAN -CORNER
TYP (UNITS)

Revisions
08/23/19 1ST ISSUE

PROPOSED NEW BLDG #5 (7 UNITS)
THE VILLAGES AT MIAMI GARDENS
3400 191 ST.
MIAMI GARDENS, FL. 33056-2936

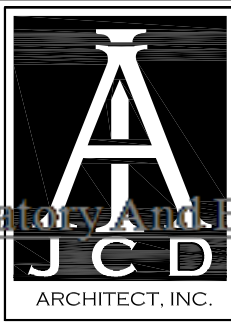

JCD ARCHITECT, Inc.
JUAN C. DAVID R.A. # 0015344
Design & Development
LEED ACCREDITED PROFESSIONAL
Architecture Interiors Planning Construction

1385 Coral Way, Suite 404 Miami, Florida 33145 Phone: (305) 285-4343 Fax: (305) 285-4330

Job No. AA-26000666
Date 11/14/2019 12:30:25 PM
Scale SHOWN
Seal
Sheet No. E-2

Miami Dade County Department of Regulatory and Economic Resources - Full Copy
3419015913
E-2.1 09252019.pdf