



Schedule									
Symbol	Label	QTY	Catalog Number	Number Lamps	Lumens per Lamp	Lamp	Description	LLF	Wattage
○	A	12	DL556-3012-120-4K-MH	1	1290.49	12x white LEDs	Circular white aluminum housing with clear inner lens and frosted outer lens	1	17.539

Statistics		Avg	Max	Min	MaxMin	AvgMin
Description	Symbol					
Cate Zone #1	+	16.2 t	19.5 t	13.4 t	1.5 t	1.2 t
Cate Zone #1 (copy)	+	16.2 t	19.5 t	13.4 t	1.5 t	1.2 t
Cate Zone #1 (copy)	+	16.2 t	19.5 t	13.4 t	1.5 t	1.2 t
Cate Zone #1 (copy)	+	16.2 t	19.5 t	13.4 t	1.5 t	1.2 t
#1 (COP) (copy)	+	16.2 t	19.5 t	13.4 t	1.5 t	1.2 t


1. Please Contact: Giovanni A. Perez at Contemporary Lighting Sales
786-344-2660 or (GAP0210@GMAIL.COM)
For procurement of the specified lighting equipment.

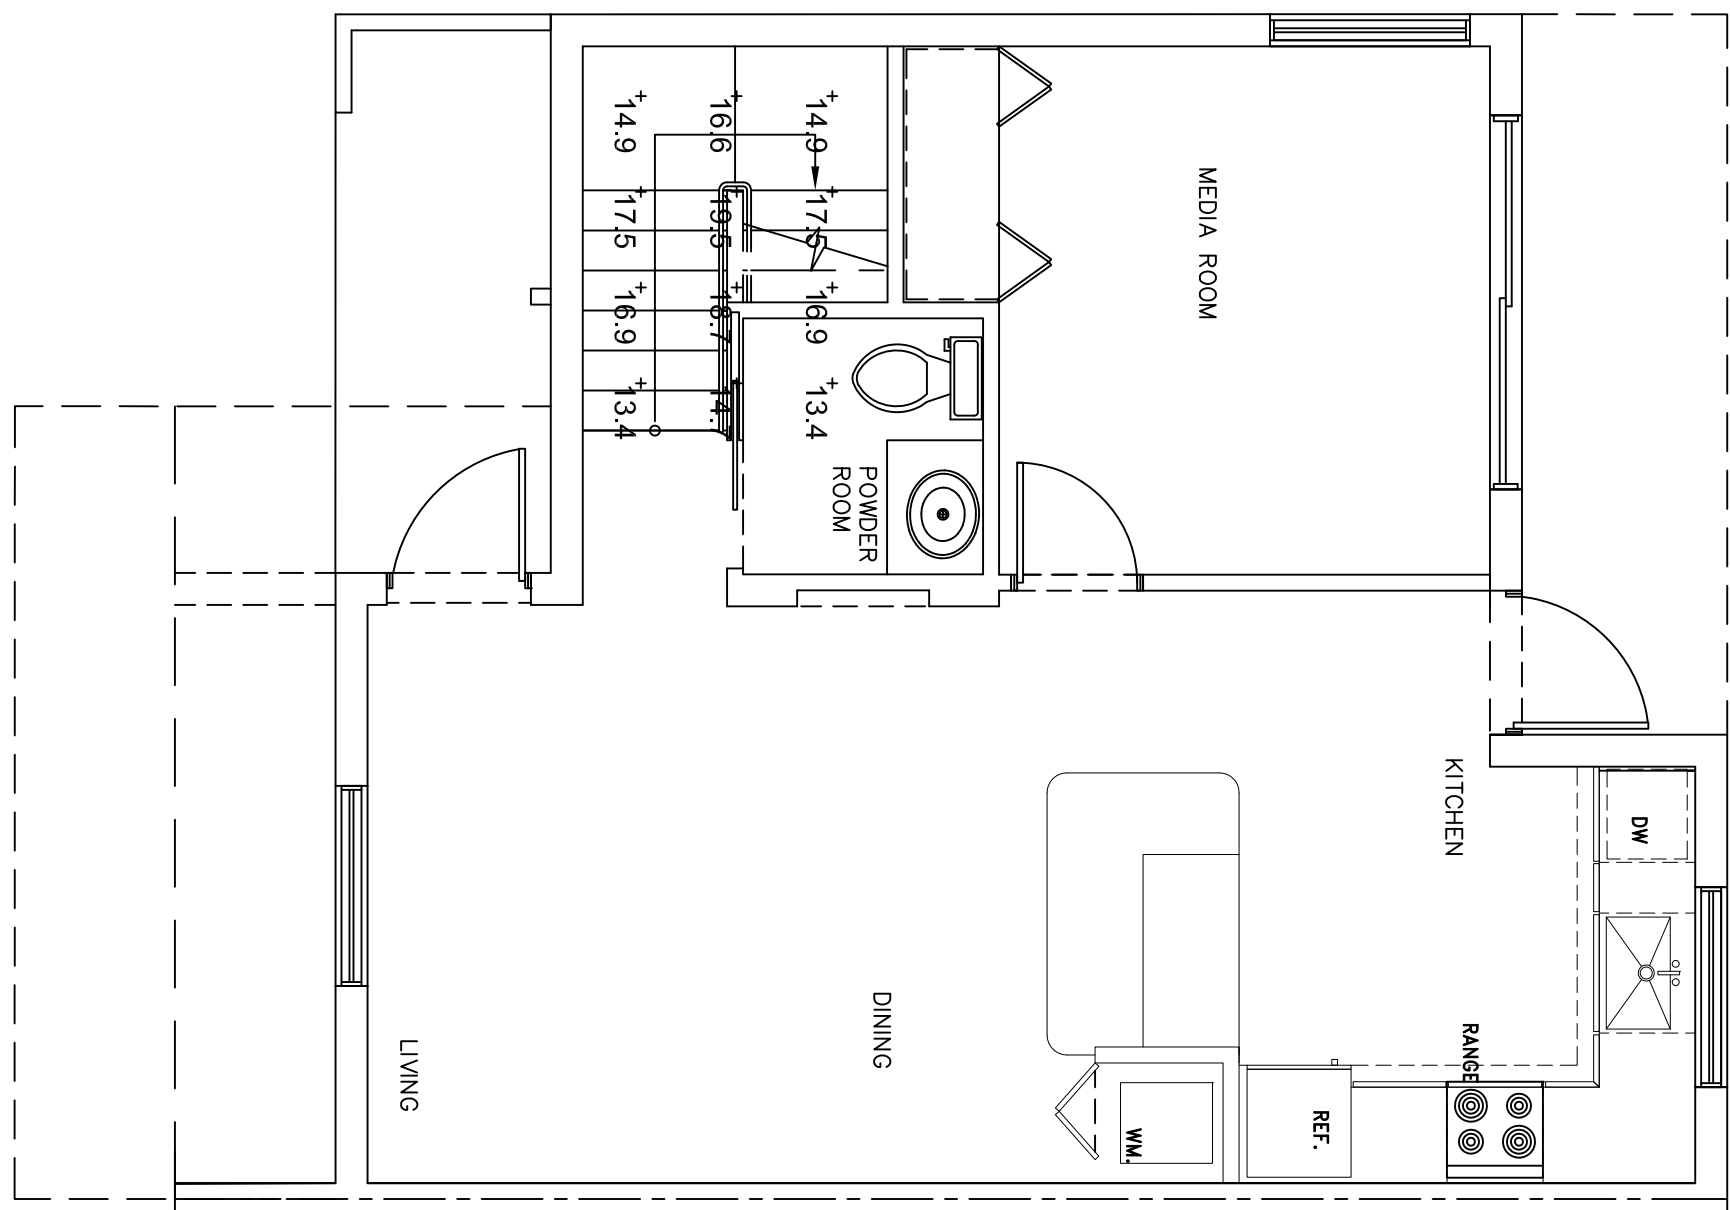


GROUND FLOOR PLAN -CORNER
TYP (UNITS)

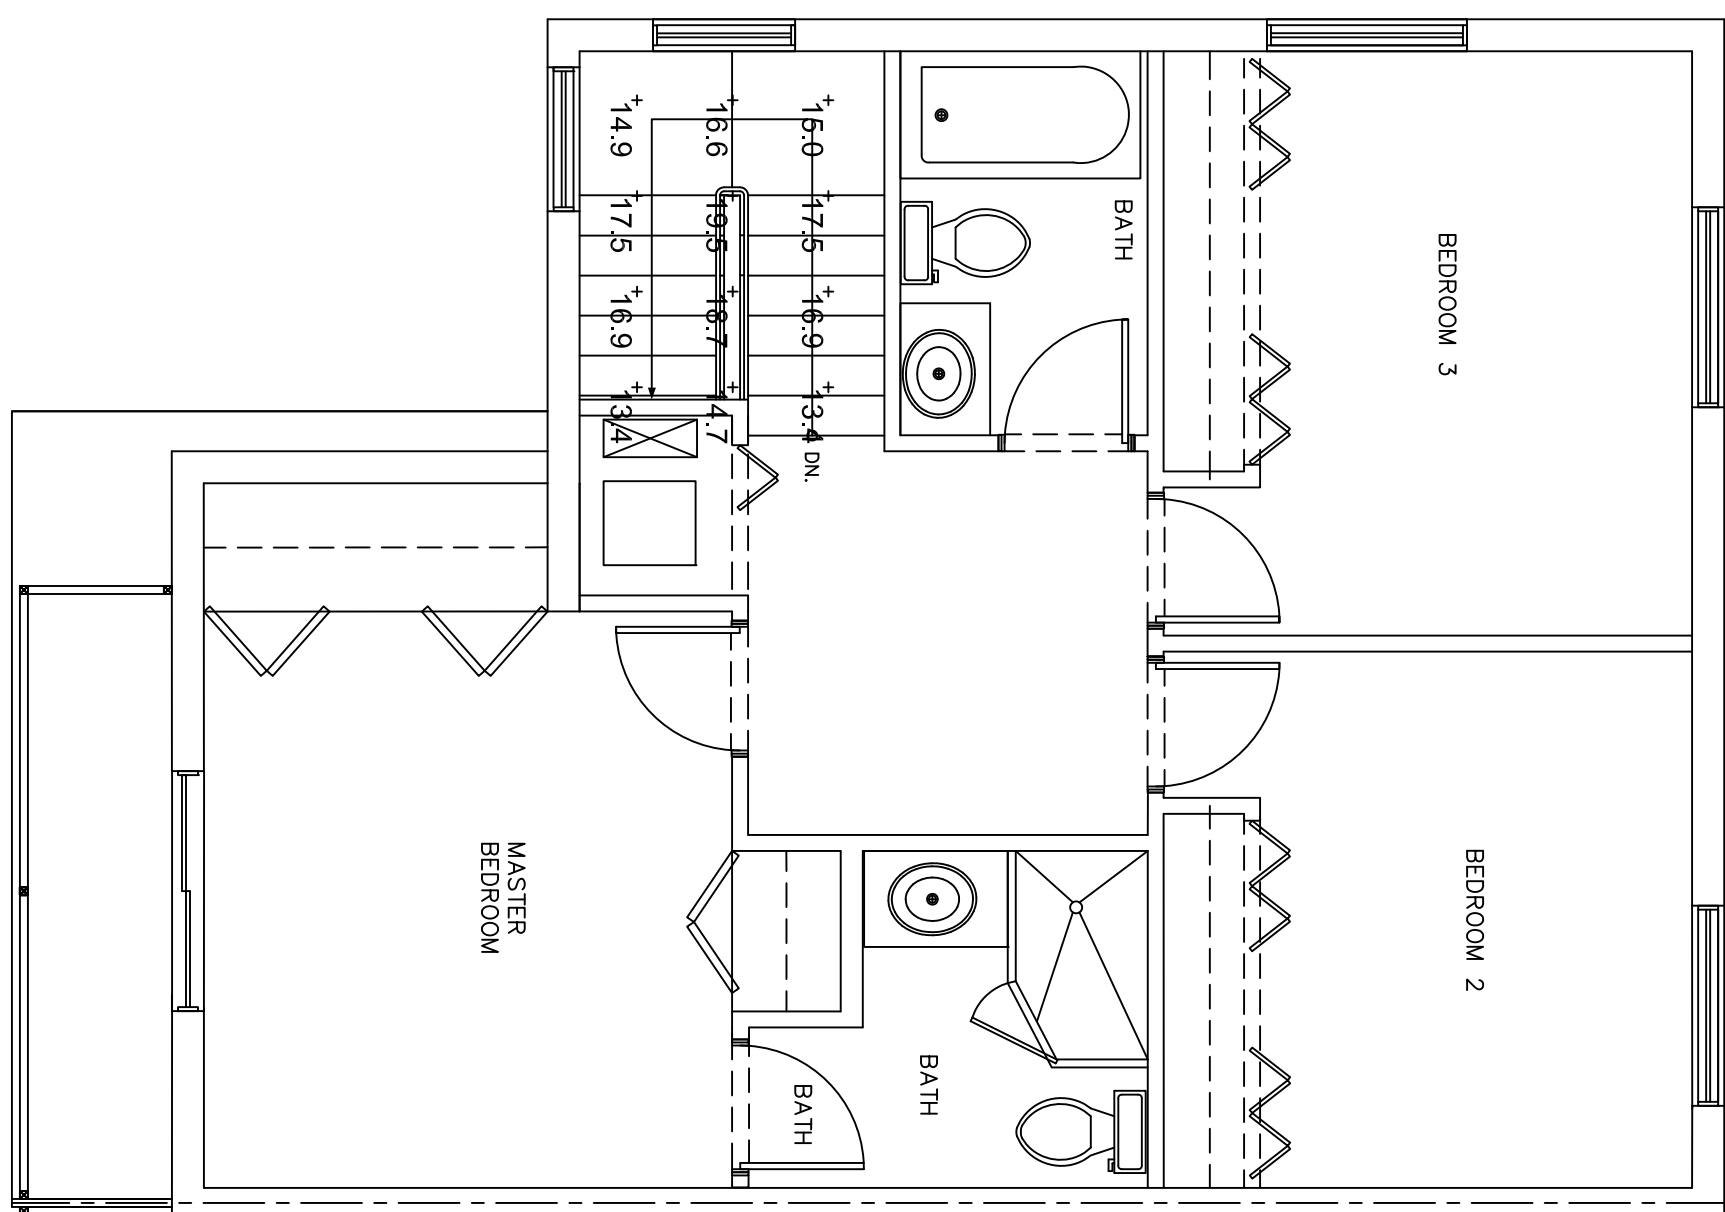

SECOND FLOOR PLAN -CORNER
TYP (UNITS)

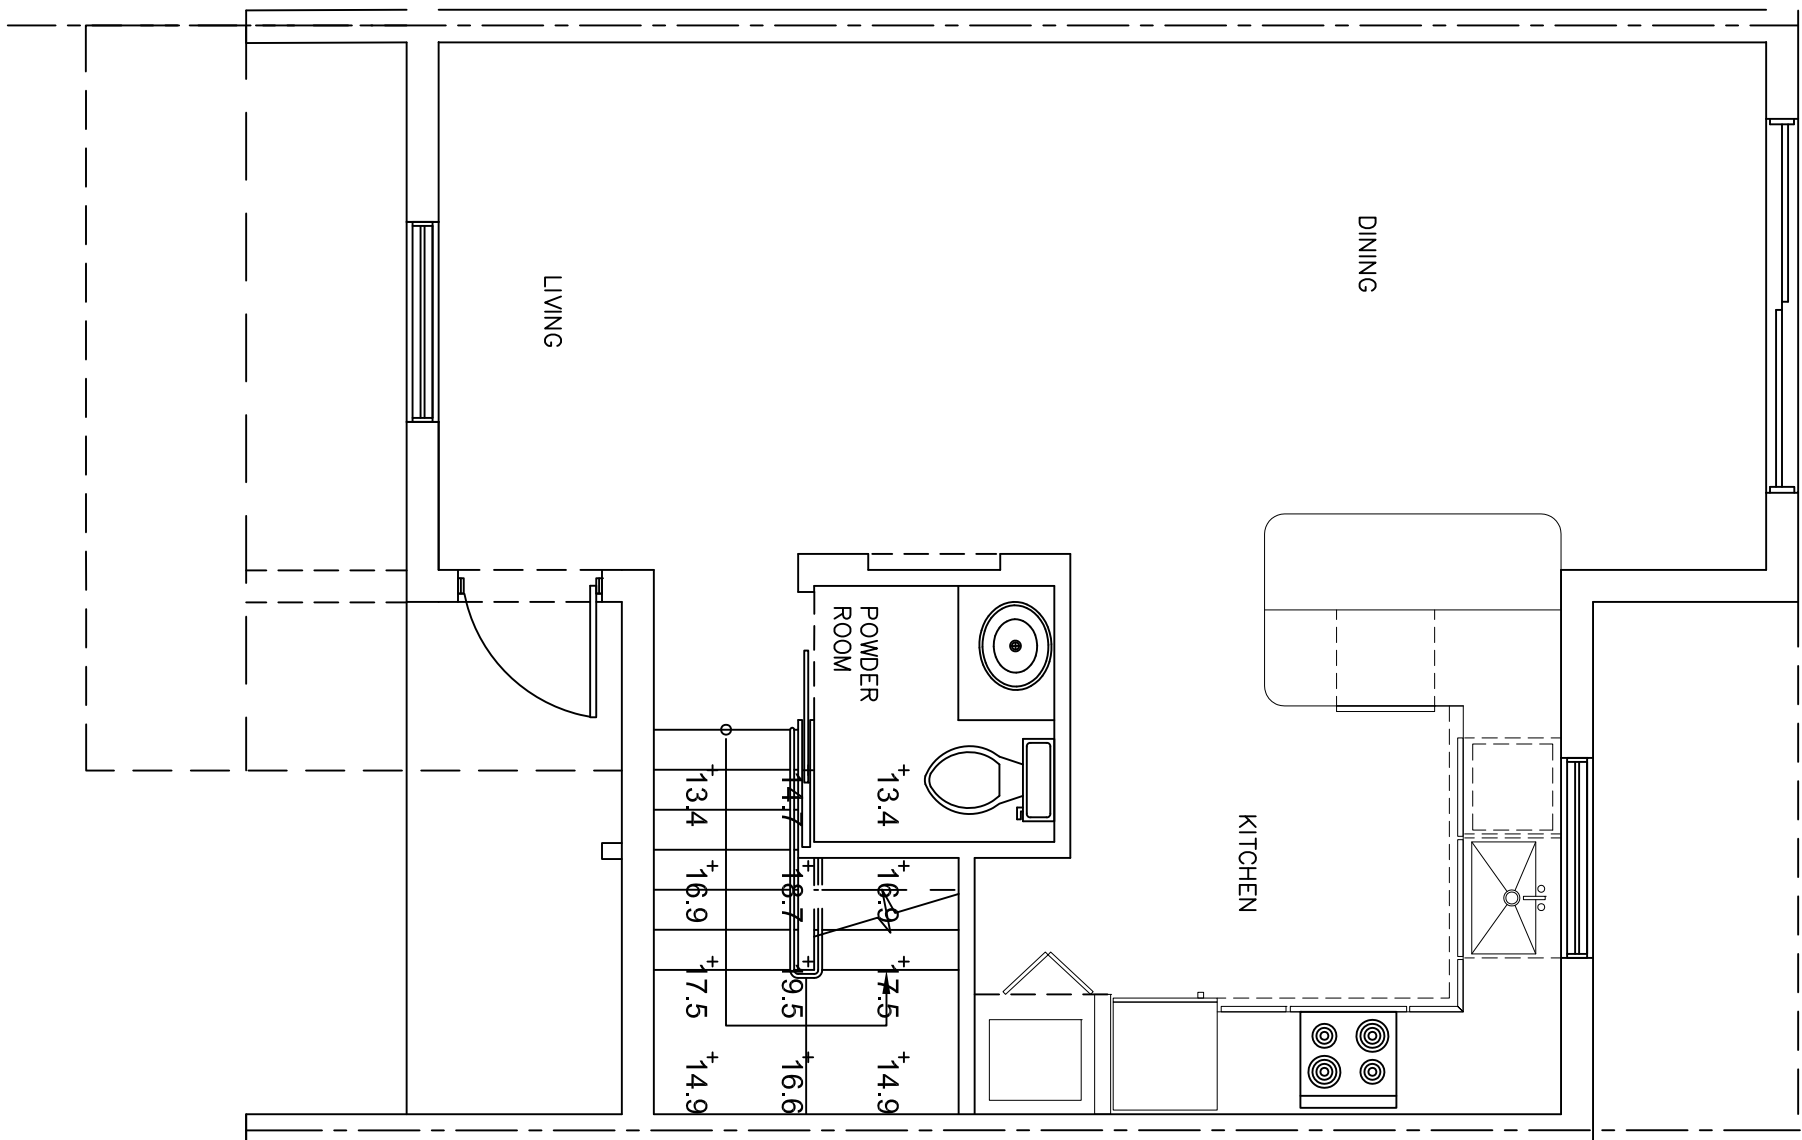

GROUND FLOOR PLAN -CORNER
TYP (UNITS)

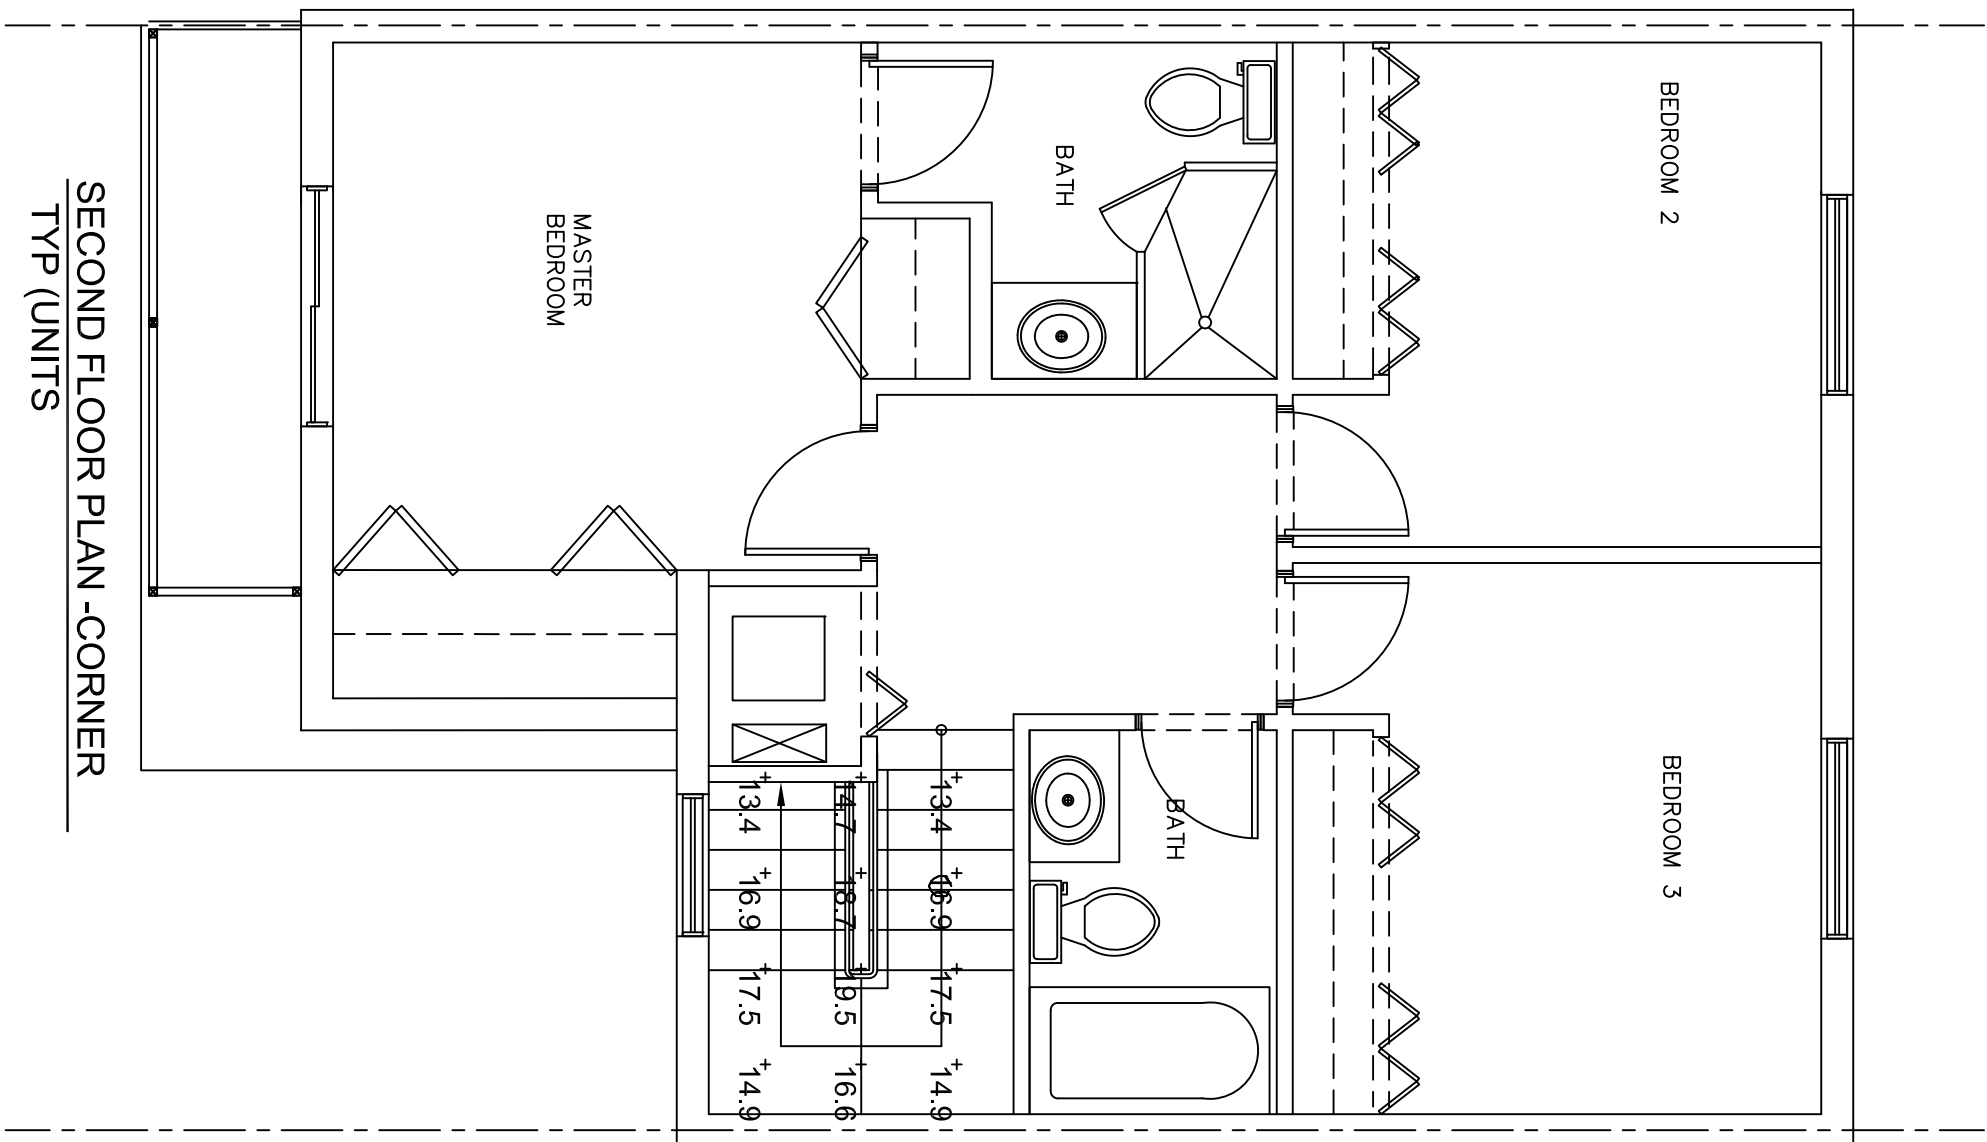

SECOND FLOOR PLAN - CORNER
TYP (UNITS)

PHOTOMETRIC FLOOR PLAN

SCALE: 1/4"= 1'-0"

Revisions
08.23.19 1ST ISSUE

PROPOSED NEW BLDG #6 (7 UNITS)
THE VILLAGES AT MIAMI GARDENS
3400 191 ST.
MIAMI GARDENS, FL. 33056-2936

JCD ARCHITECT, Inc.
JUAN C. DAVID R.A. # 0015344
Design & Development
LEED ACCREDITED PROFESSIONAL
 Architecture Interiors Planning Construction
 1385 Coral Way, Suite 404 Miami, Florida 33145 Phone: (305) 285-4343 Fax: (305) 285-4330

Seal	AA-26003566	Sheet No.	E-2
------	-------------	-----------	-----

Miami Dade County Department of Regulatory And Economic Resources - Info Copy
3419015772 11/14/2019 12:33:16 PM
B-2 1 00252810.pdf

JCD
 ARCHITECT, INC.
 1385 Coral Way, Suite 404 Miami, Florida 33145 Phone